


LEGEND

- DUPLEX OUTLET
18" A.F.F. UNLESS
NOTED OTHERWISE
- GFI
GROUND FAULT
INTERUPTER
- SOFFIT RECESSED
LIGHT FIXTURE
- 2x4 FLUORESCENT
LIGHT FIXTURE -
RECESSED
- WALL LIGHT

ELECTRICAL PLAN

SCALE: 1/4" = 1'-0"

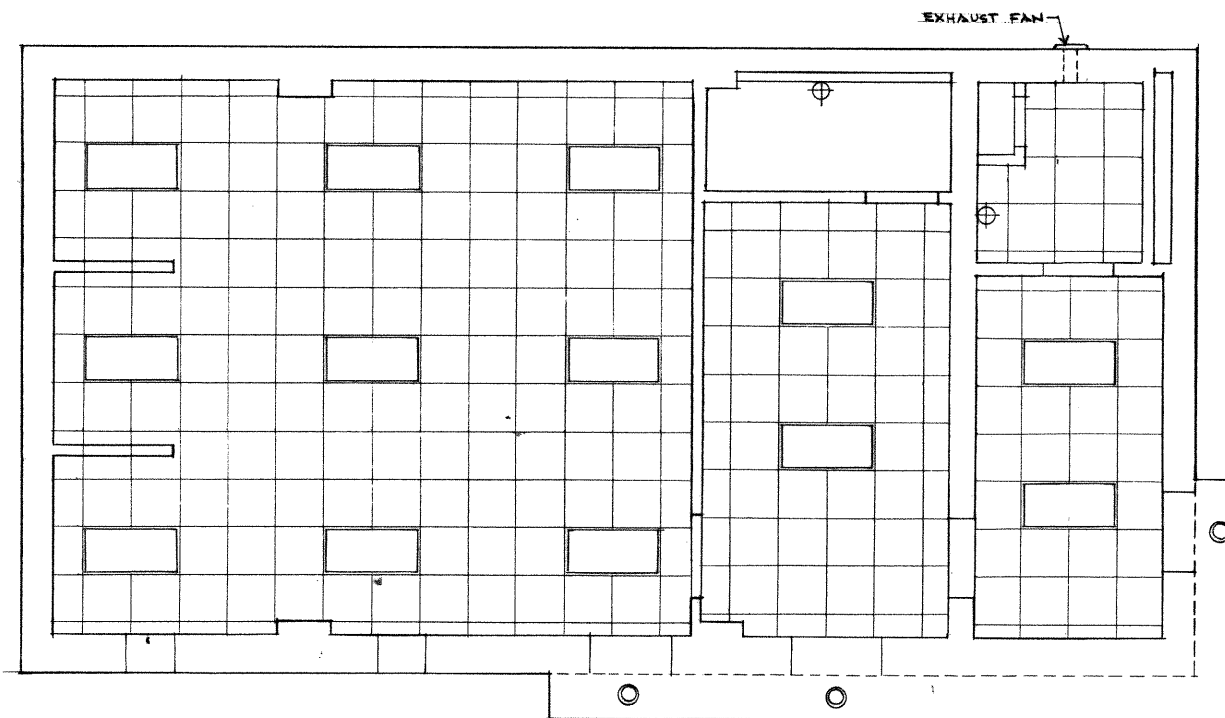

REFLECTED CEILING PLAN

SCALE: 1/4" = 1'-0"

Ukrainian Museum and Archives
1202 Kenilworth Ave
Cleveland, Ohio 44113
Ph: (216) 781-4329 Fax: (216) 781-5844

ANNEX BUILDING RENOVATION

ELECTRICAL PLANS

EACONSULTANTS LLC
4055 Williamsburg Court MEDINA, OHIO 44256 | 440.552.9027

SCALE	DRAWN	CHECKED	APPROVED				
AS NOTED	EL	PN	PN				
DEPT.	ARCH.	STRUCT.	MECH.	ELECT.	PIPING	EQUIP.	P.E.
INIT.	LEB			PH			PN
DATE	6-11-16			6-17-16			7-1-16
WORK ORDER NO.	SHEET NO.		REV.				
2016-1	E-1						